



1 FIRST FLOOR 2 STORY UNIT SANITARY PLAN
1/4" = 1'-0"

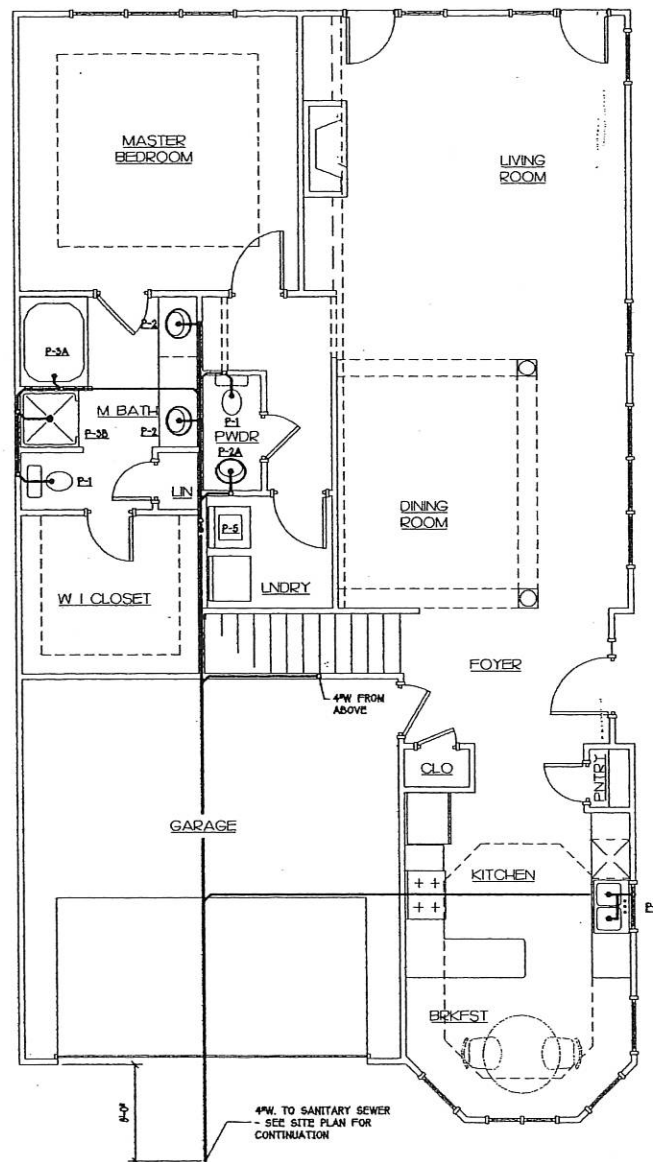

2 FIRST FLOOR 2 STORY UNIT (ALT) SANITARY PLAN
1/4" = 1'-0"

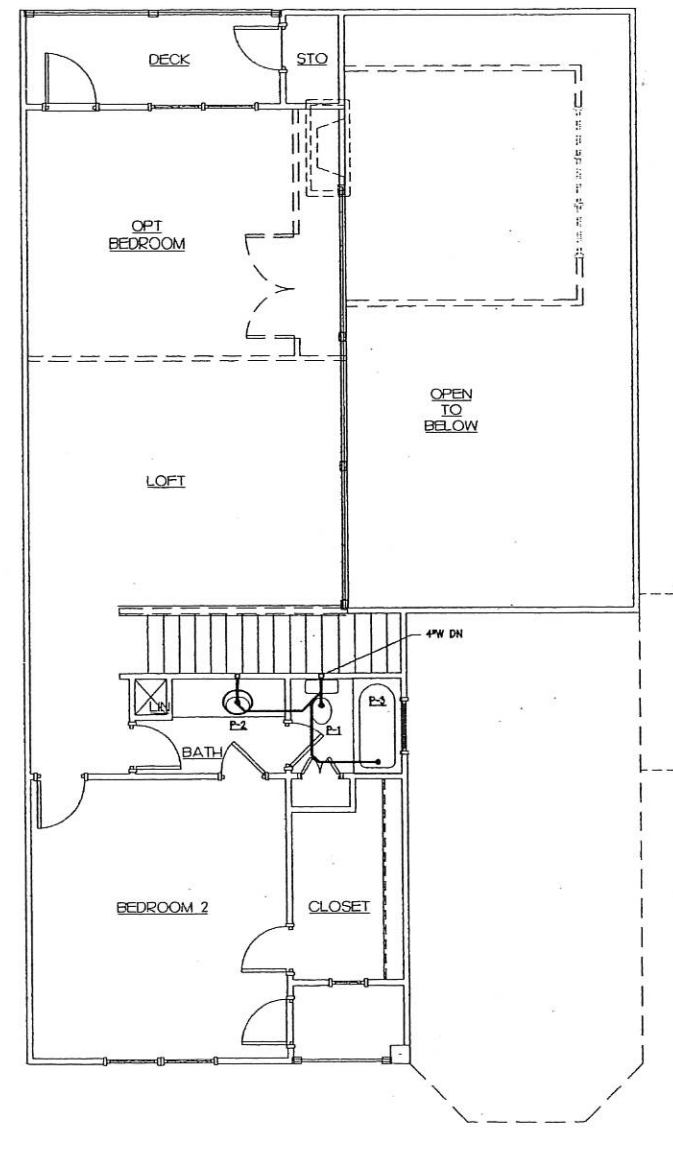

3 SECOND FLOOR 2 STORY UNIT SANITARY PLAN
1/4" = 1'-0"

- PLUMBING NOTES FOR UNIT PLANS:**
- SEE SHEET P4 FOR FIXTURE SCHEDULE & CONNECTION SIZES.
 - ALL WATER SUPPLY LINES IN AN EXTERIOR WALL SHALL BE RUN ON INTERIOR SIDE OF WALL INSULATION.
 - PROVIDE SHUT-OFF VALVE IN EACH UNIT IN AN ACCESSIBLE LOCATION THAT CONTROLS ALL WATER SUPPLY TO THAT UNIT.
 - ALL WATER PIPING IS 1/2" UNLESS OTHERWISE NOTED.
 - PROVIDE ALL REQUIRED PLUMBING CONNECTIONS FOR DISHWASHER AND DISPOSAL IN EACH UNIT PER MFR RECOMMENDATIONS.
 - PROVIDE CLEANOUT AT THE BASE OF ALL WASTE STACKS.



**LAKE SHORE
TOWN
HOMES**

Tega Cay,
South Carolina

DATE DRAWN:	06/09/05
PROJECT NO.:	2530
ISSUE FOR:	Permit & Construction: